


**LEGEND**

- STAGE 7 BOUNDARY ---
- STORMWATER DRAINAGE —SWD—
- STORMWATER SWALE - - - - -
- ROOFWATER DRAINAGE —
- SEWER RETICULATION —S—
- WATER RETICULATION —W—
- ELECTRICAL LAYOUT - - - - -
- STREET TREES +
- INDICATIVE DRIVEWAY LOCATION ▼

**CONCEPT PLAN ONLY**  
NOT TO BE USED FOR  
CONSTRUCTION PURPOSES

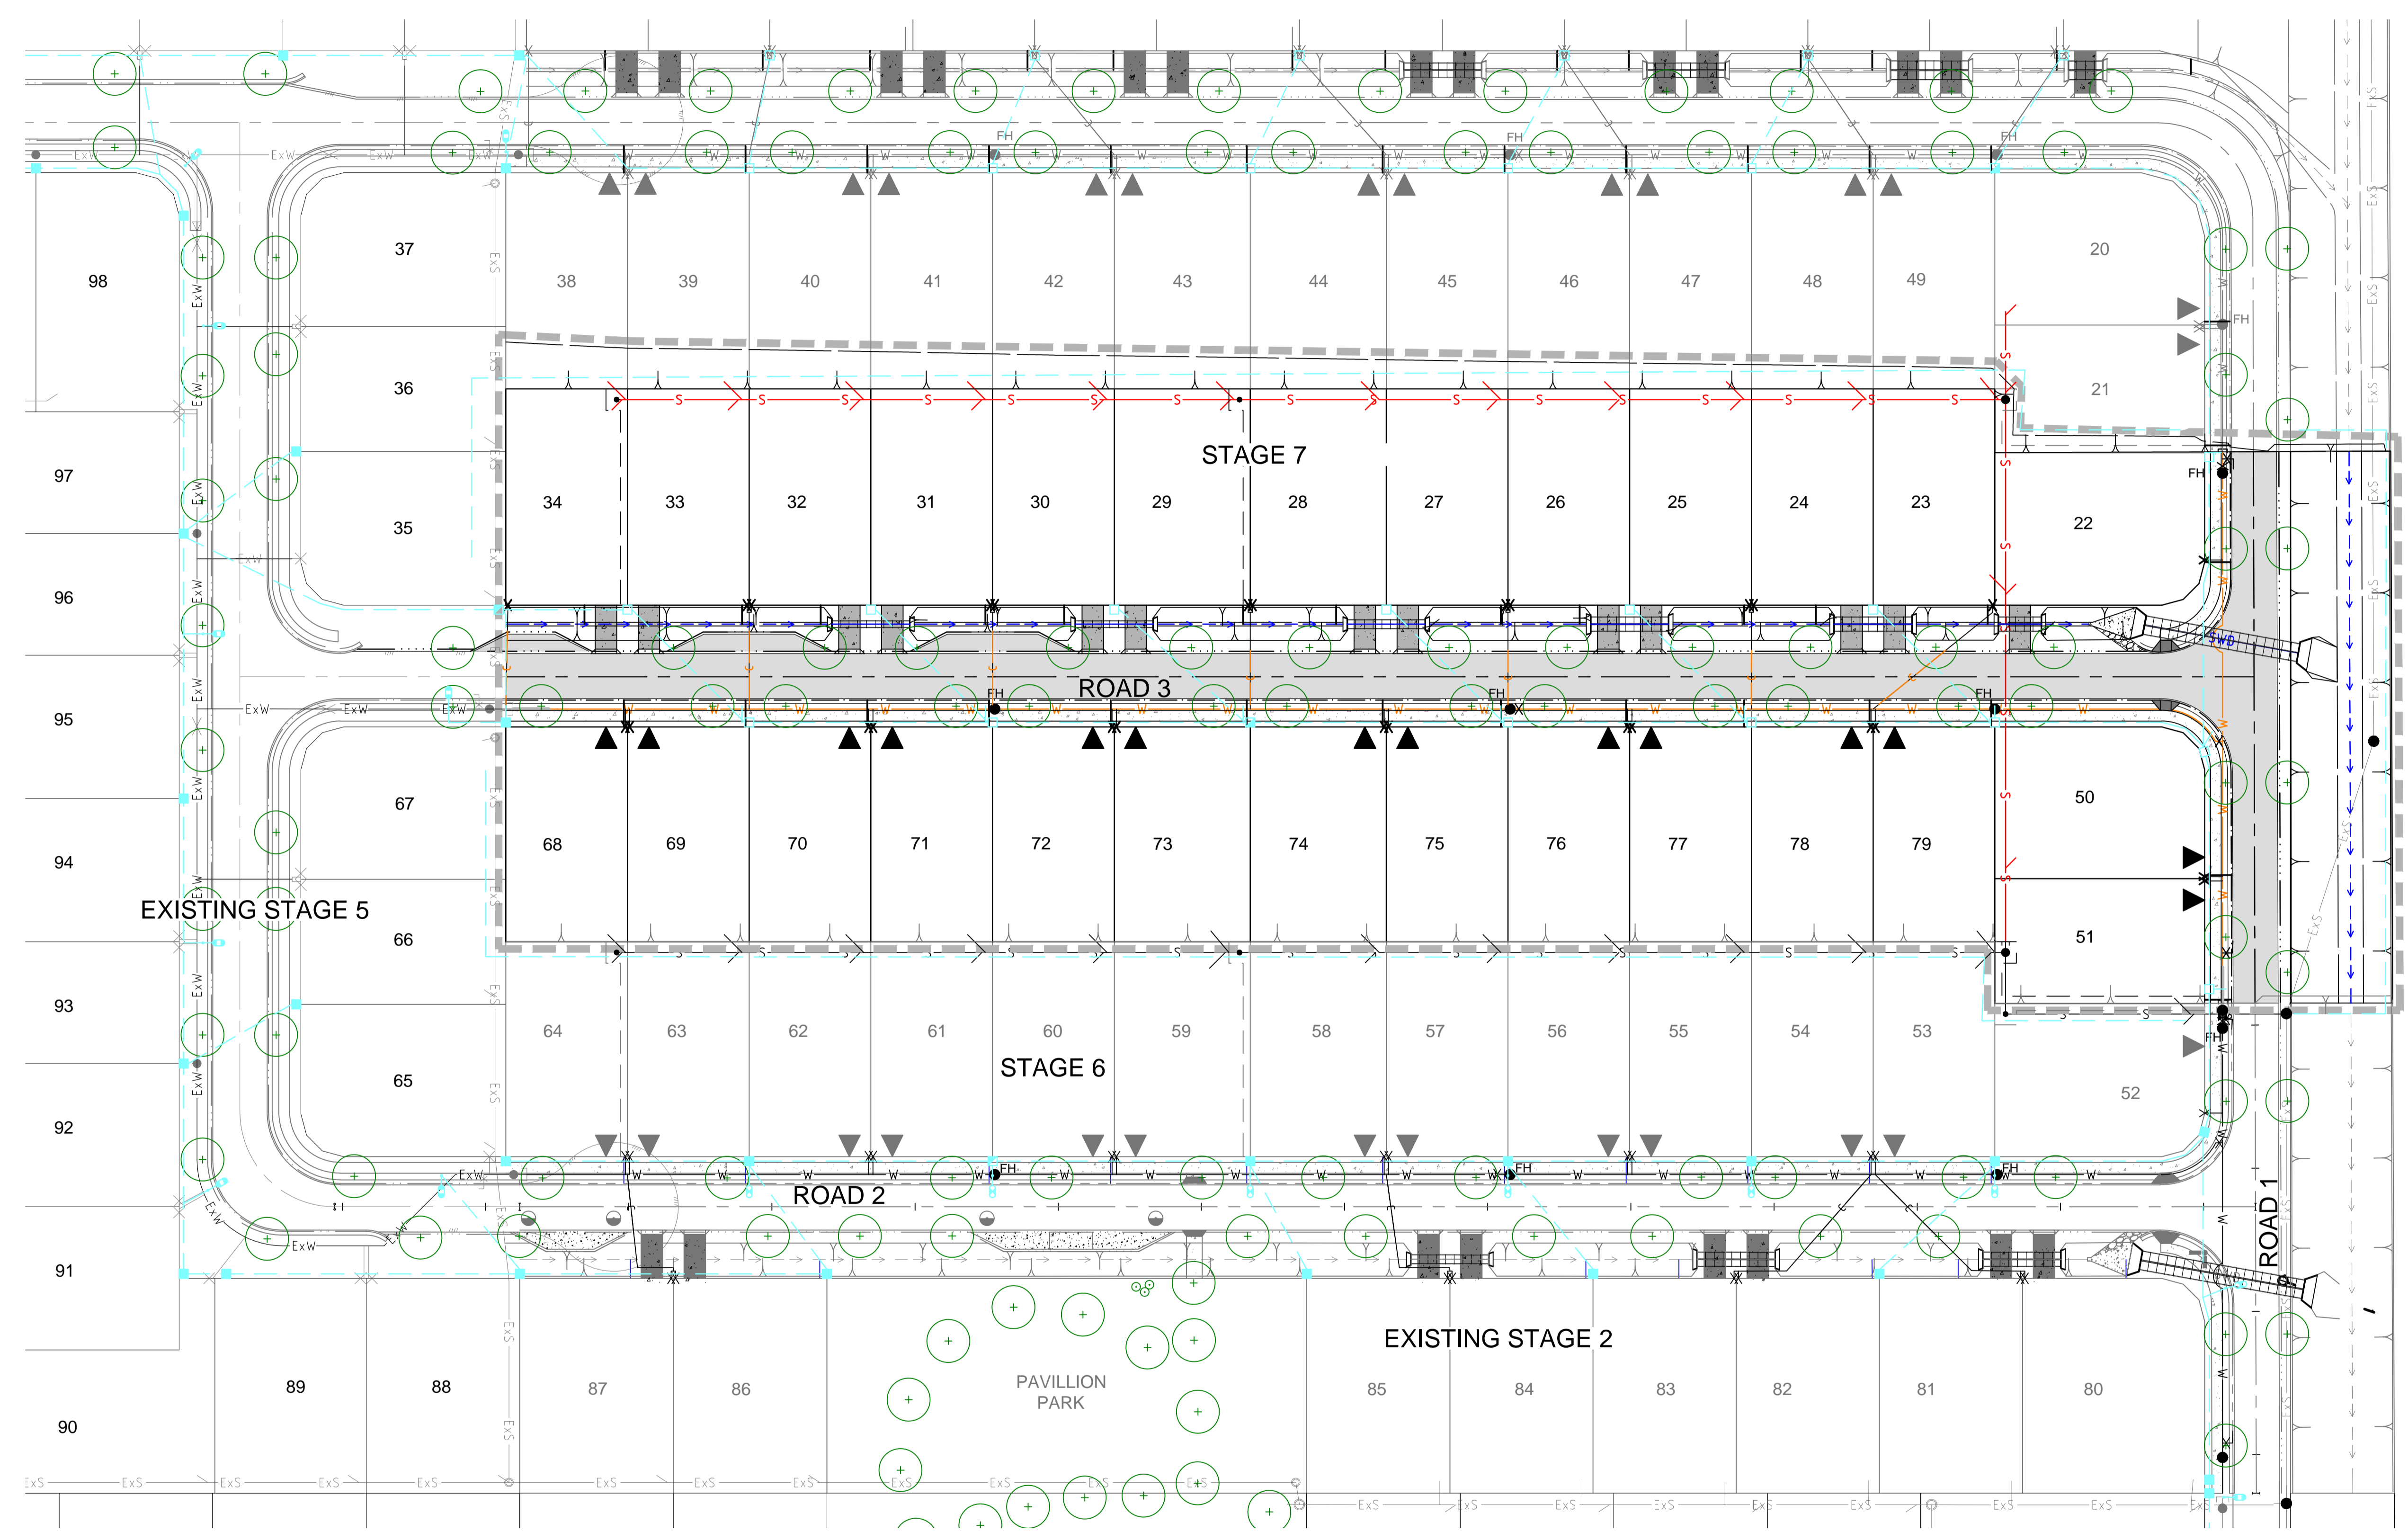


ADJOINING LOT 2 RP90058

© COPYRIGHT of this design and plan is the property of ACOR Consultants (QLD) Pty Ltd, ACN 126 011 087 ABN 18 126 011 087, all rights reserved. It must not be used, modified, reproduced or copied wholly or in part without written permission from ACOR Consultants (QLD) Pty Ltd. ACOR Consultants is a trademark licensed to ACOR Consultants (QLD) Pty Ltd by ACOR Consultants Pty Ltd.

(I.C.C.) REF No. - 7775/2016/OW NOT FOR CONSTRUCTION

This drawing has been assigned an electronic code that signifies the drawing has been checked and approved by:				
A	ISSUED FOR INFORMATION ONLY	AUG 2017	JB	PAJ
Issue	Description	Date	Drawn	Approved

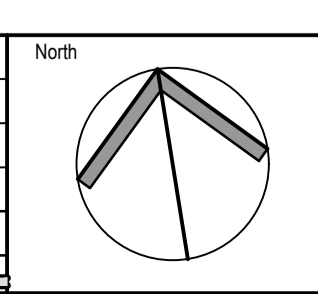

Client  
**RESIDDEV QLD PTY LTD**  
12/2 QUAMBY PLACE  
NOOSA HEADS 4567 QLD  
PHONE : (07) 5455 5888

Scales

**ACOR**  
CONSULTANTS

ENGINEERS | MANAGERS | INFRASTRUCTURE PLANNERS | DEVELOPMENT CONSULTANTS

**ACOR Consultants (QLD) Pty Ltd**  
Level 4, 43 Peel Street  
South Brisbane QLD 4101  
T +61 7 3844 5900

Project  
**RESIDENTIAL DEVELOPMENT  
ROSEHAVEN STAGE 7**

23-45 BASSETT LANE  
ROSEWOOD, QLD, 4340

Drawing Title <b>COMBINED SERVICES LAYOUT PLAN</b>				
Drawn	Date	Scale	A1	G.A. Check
JB	AUG. 2017	AS SHOWN	PAJ	AUG. 2017
Designed	Project No.	Dwg. No.	Issue	
AY	BR160364	CSK.01	A	

Project: BR160364 - Rosehaven Stage 7 - Combined Services Layout Plan - 2017-08-01